


ISO A3 297mm x 420 mm
A
B
C
D



2 3D VIEW
NTS

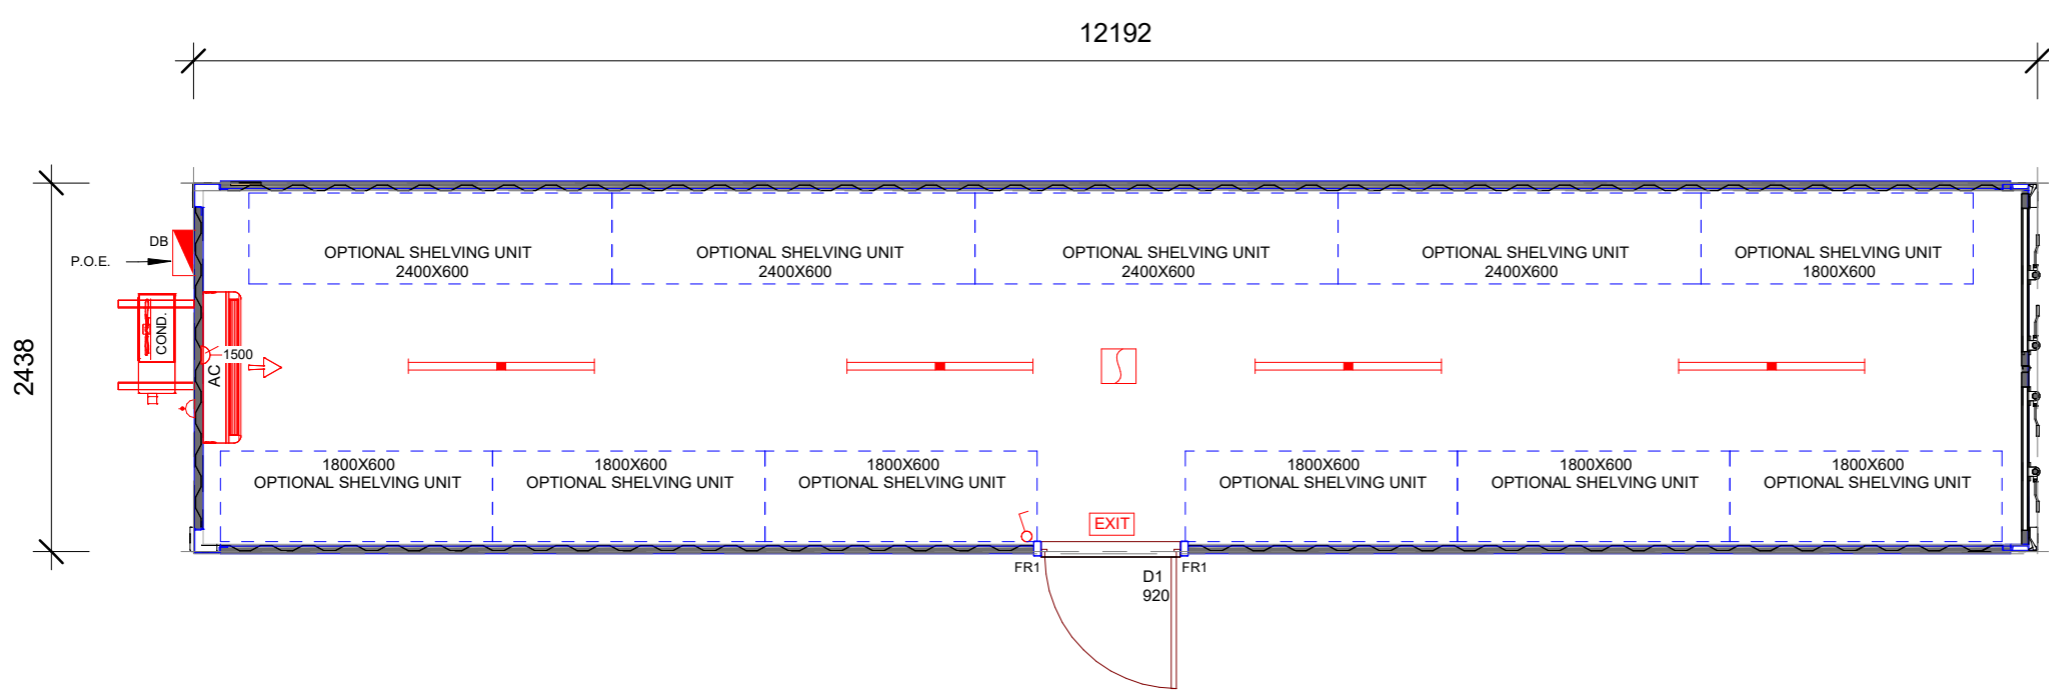

1 FLOOR PLAN
1 : 50

THIS DRAWING IS PROTECTED BY COPYRIGHT LAWS.
DO NOT SCALE DRAWING.
REF TO DIMENSIONS ONLY.

PROJECT:
40'GP CONTAINER STORE ROOM
LOCATION:
EX WORKS

CLIENT:
ISC

PROJECT TEAM INITIALS:

DRAWN BY:	LL
CHECKED BY:	SCR
APPROVED BY:	SCR

THIS DRAWING IS TO BE PAINTED IN COLOR

REV NO.	DATE	DESCRIPTION
01	03.05.23	INITIAL ISSUE

PROJECT NORTH
N
SCALE: As indicated

PROJECT NUMBER:
8082

SHEET TITLE:
FLOOR PLAN / ELECTRICAL LAYOUT
DRAWING NO:
8082-PLN

BUILDING DESIGN CRITERIA WIND LOAD
IN ACCORDANCE WITH AS.1170.2:2002
REGION A, TERRAIN CATEGORY 2