


ISO A3 297mm x 420 mm
A
B
C
D



2 3D VIEW
1 : 10

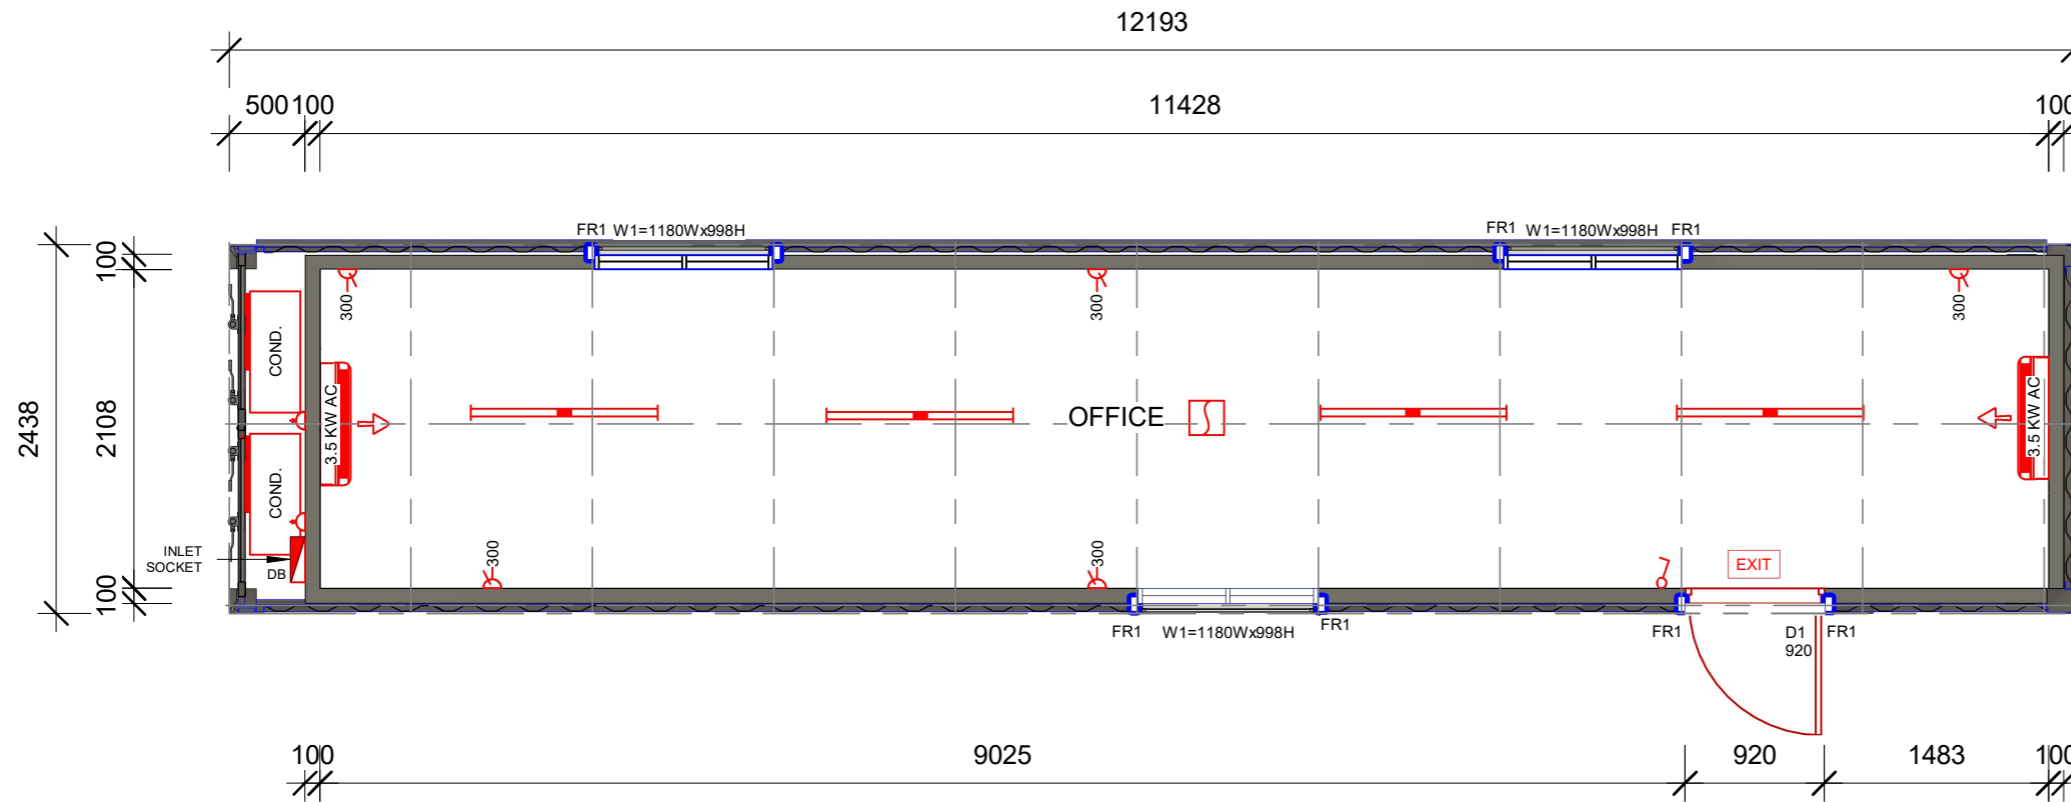

1 FLOOR PLAN
1 : 50

PROJECT:
40'HC OFFICE

LOCATION:
EX WORKS

CLIENT:
XXXX

PROJECT TEAM INITIALS:

DRAWN BY:	LL
CHECKED BY:	SCR
APPROVED BY:	SCR

THIS DRAWING IS TO BE PAINTED IN COLOR

REV NO.	DATE	DESCRIPTION
01	03.02.23	INITIAL ISSUE

PROJECT NORTH



SCALE: As indicated

PROJECT NUMBER:

8083

SHEET TITLE:

**FLOOR PLAN /
ELECTRICAL LAYOUT**

DRAWING NO:

8083-PLN

BUILDING DESIGN CRITERIA WIND LOAD
IN ACCORDANCE WITH AS.1170.2:2002
REGION D, TERRAIN CATEGORY 2